


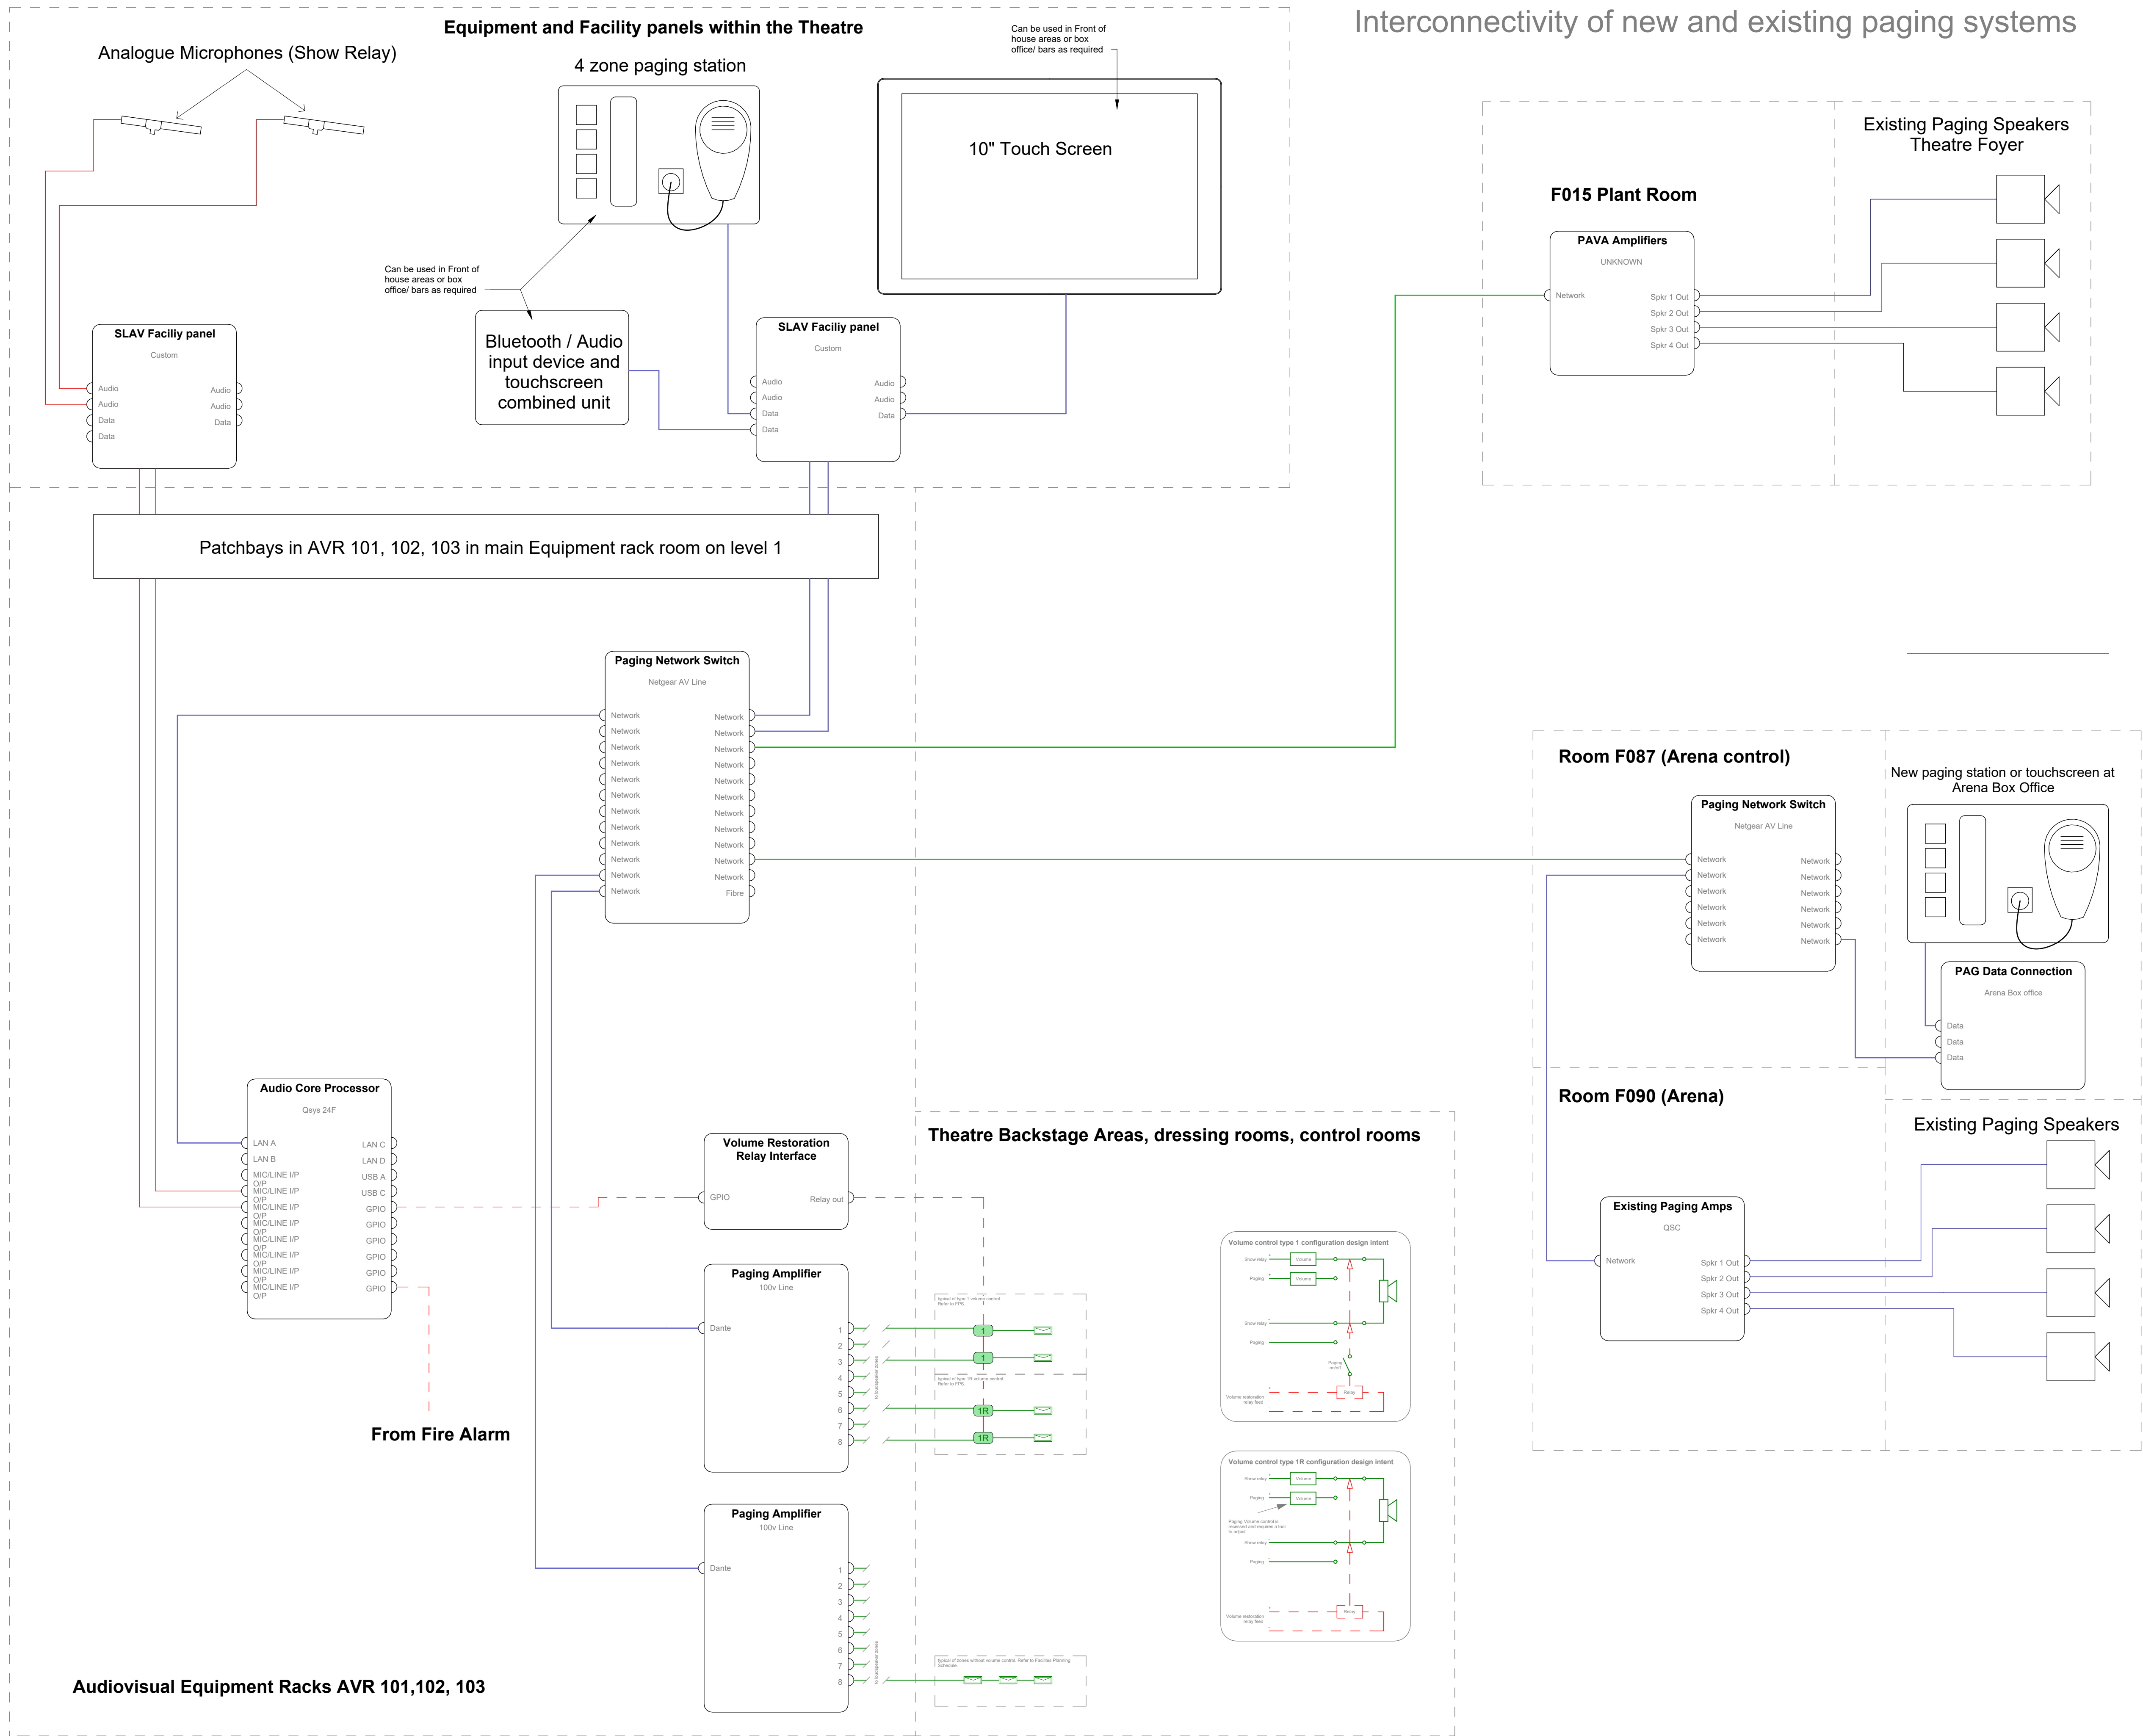

Notes:-

This drawing must be printed in colour for clarity.

All dimensions to be verified on site.
Do not scale from this drawing

This schematic drawing shows the connections between the new paging system and the existing paging systems within the venue.

Not all connections are shown for simplicity and not all existing cable types have been verified.

For detailed connections see schematic wiring diagrams. All specified equipment connections must be landed on a patchbay.

As part of the specialist contractor works, they may propose alternative solutions to connect the new and existing systems together.

The paging system requires a link from the fire alarm system so that show relay and background music can be muted in the event of an evacuation.

Key to Wiring Types	
	Cat 6A Ethernet
	Loudspeaker
	MultiMode Fibre
	GPIO
	Combined 100v / Relay paging cable
	Starquad Analogue Audio

A	TENDER	10/11/2025
Rev	Description	Date

Project title:

VENUE CYMRU, LLANDUDNO

Drawing Title:

AUDIOVISUAL SYSTEMS - PAGING

INTERCONNECTIVITY OF NEW AND EXISTING PAGING SYSTEMS

LEVEL N/A

Drawing Type:

SCHEMATIC DRAWING



17 Short Street, London SE1 8LJ
T +44 (0)20 7928 0000
www.charcoalblue.com

Scale	Size	Status	
NTS	A1	Tender	
Drawn	Date	Checked	Date
DB	30/10/25	JN	05/11/2025
DRAWING NUMBER		REV	
LVC-CBL-SLAV-SC-009		A	

Existing paging speakers and amplifiers in Theatre front of house areas and Arena areas are proposed to be retained, subject to assessment by the specialist subcontractor and advice from a Fire Consultant due to the existing FOH theatre paging system being part of the PAVA system. All paging speakers in the theatre backstage areas, dressing rooms, stage, galleries and control rooms are to be replaced. See zoning drawings provided by the venue (LVC-CBL-PAG-GA-009/10/11) indicating current zoning and control.