











REFERENCE DRAWINGS

DRAWING No.	DATE	REV
3088 (03)100	09/06/16	B
DRAWING TITLE		
Floor Plans		


SPRINKLER LEGEND

-  PENDANT HEAD
-  CONCEALED PENDANT HEAD
-  CONCEALED GLASS BULB HEAD
-  SIDEWALL HEAD
-  20mm PIPEWORK
-  25mm PIPEWORK
-  32mm PIPEWORK
-  40mm PIPEWORK
-  50mm PIPEWORK
-  65mm PIPEWORK


Flow switch



FLOWSWITCH DETAIL

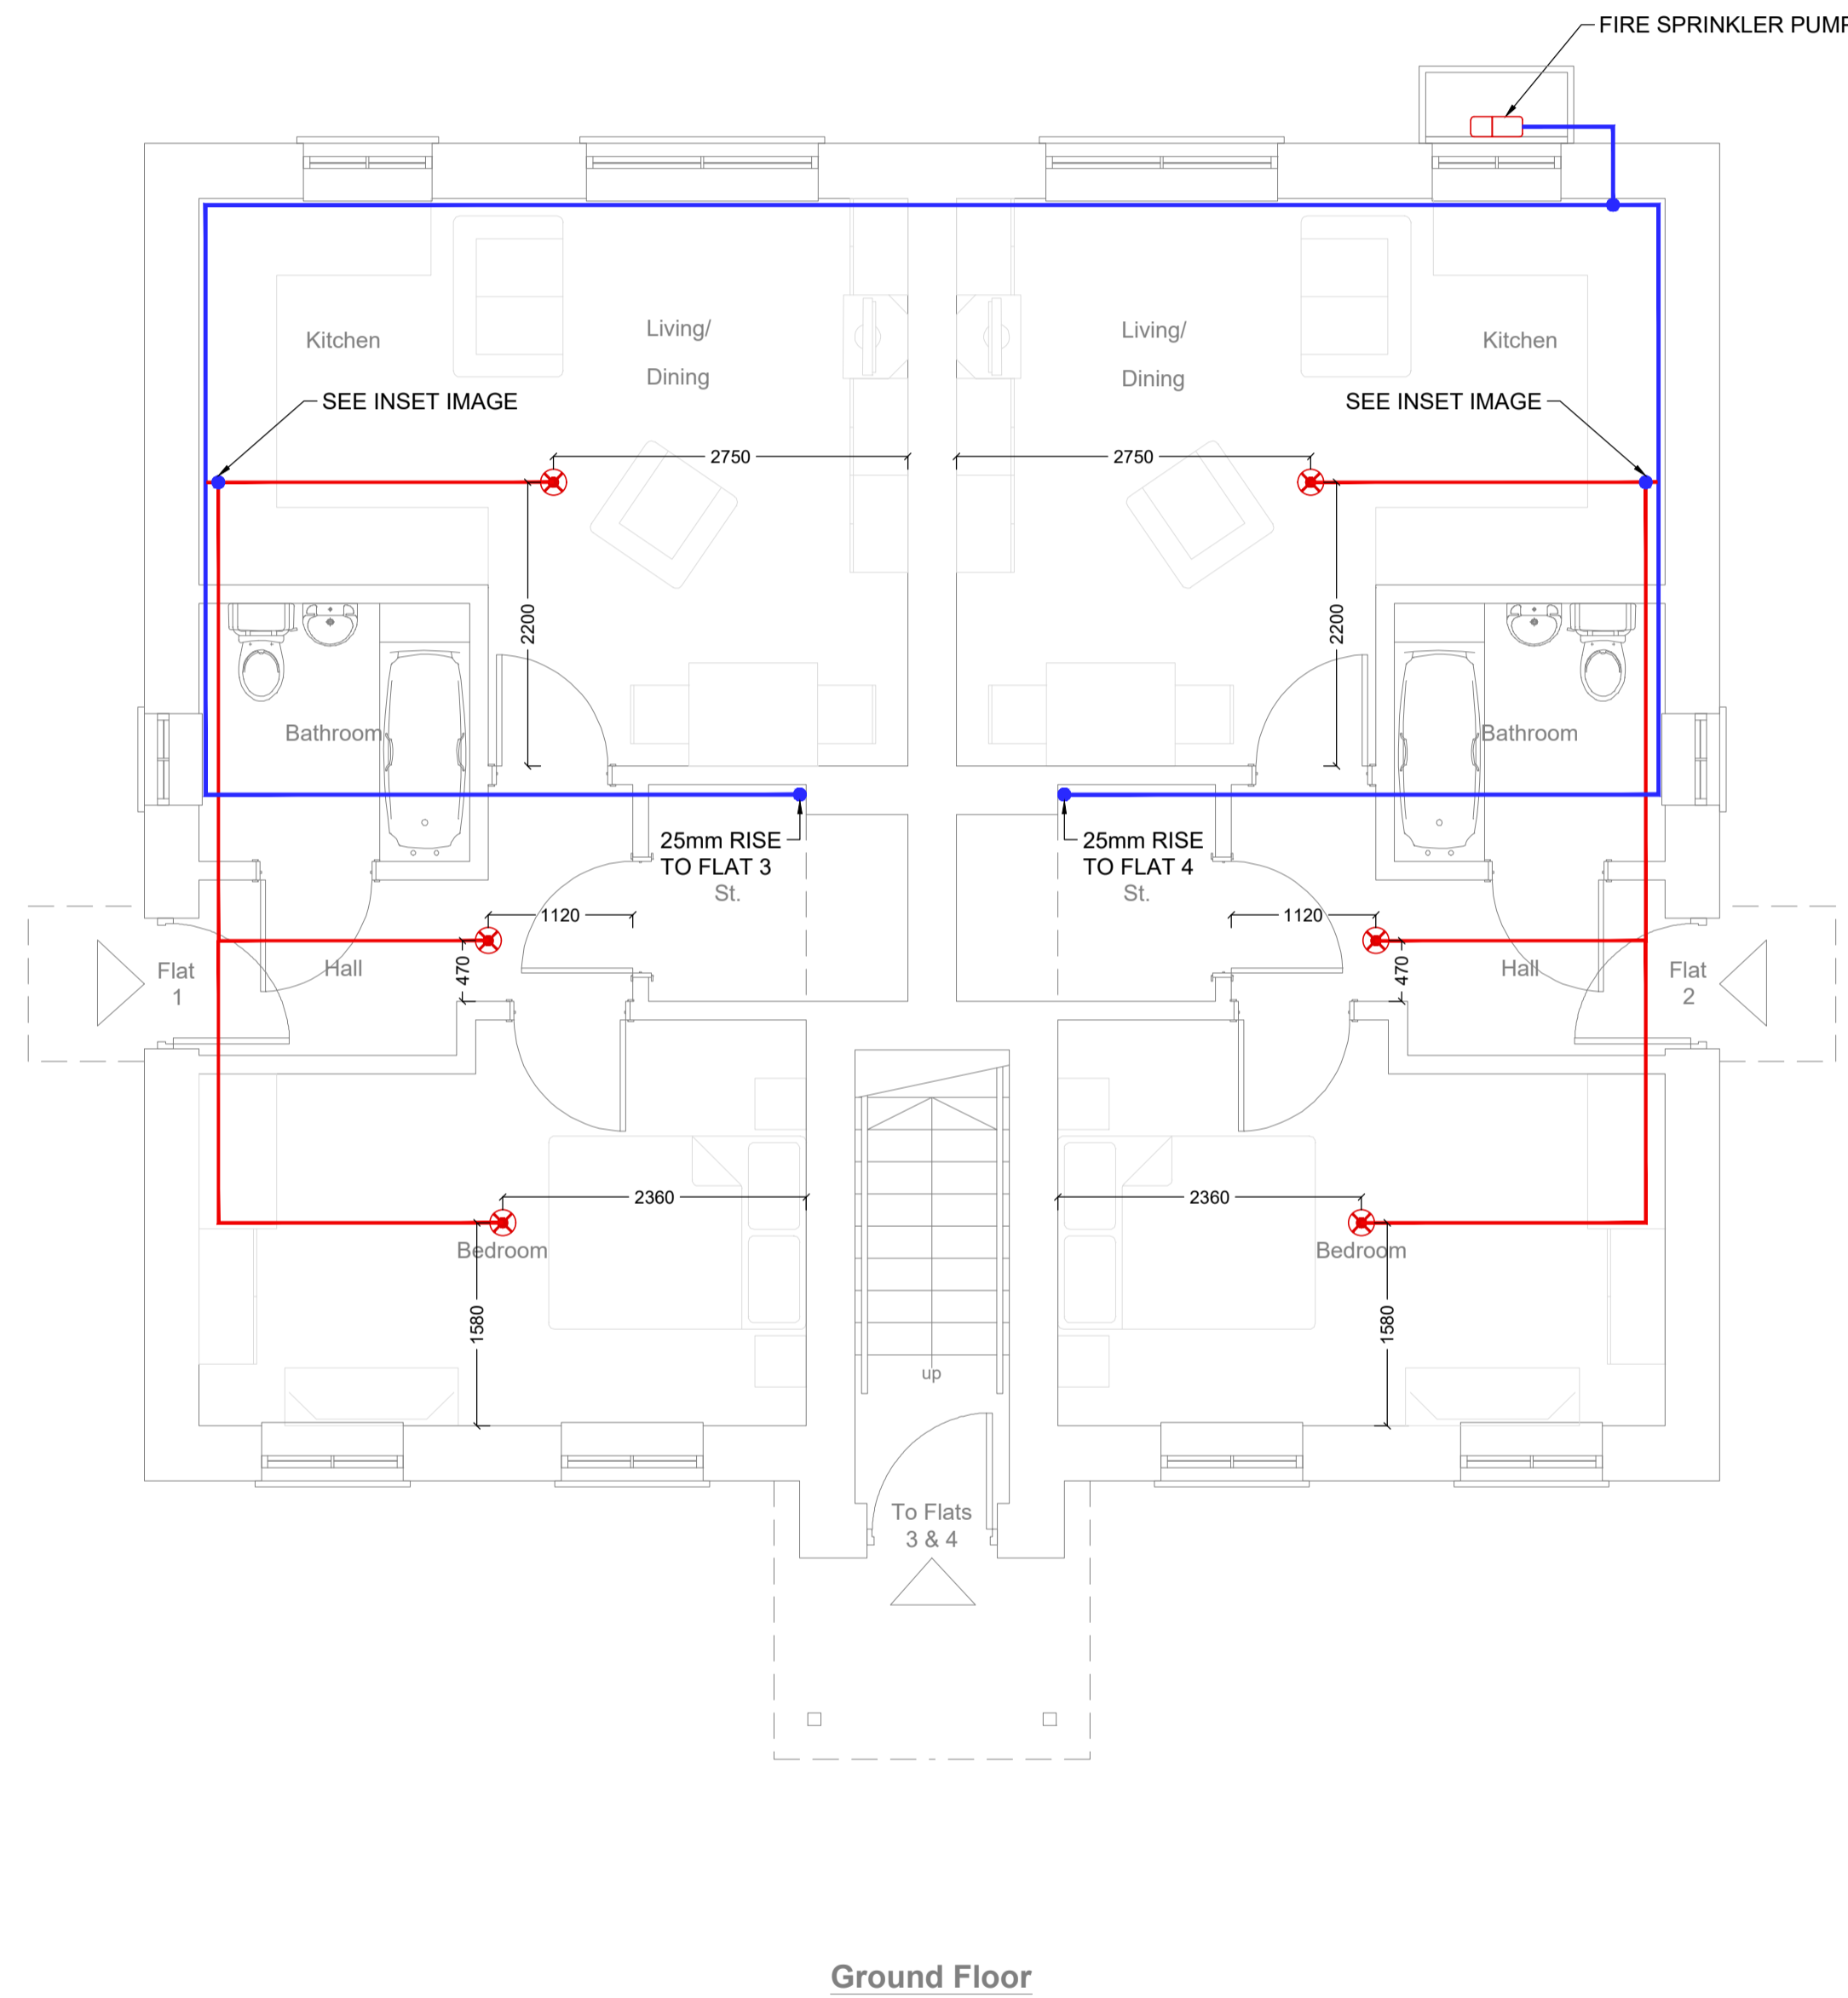

Ground Floor

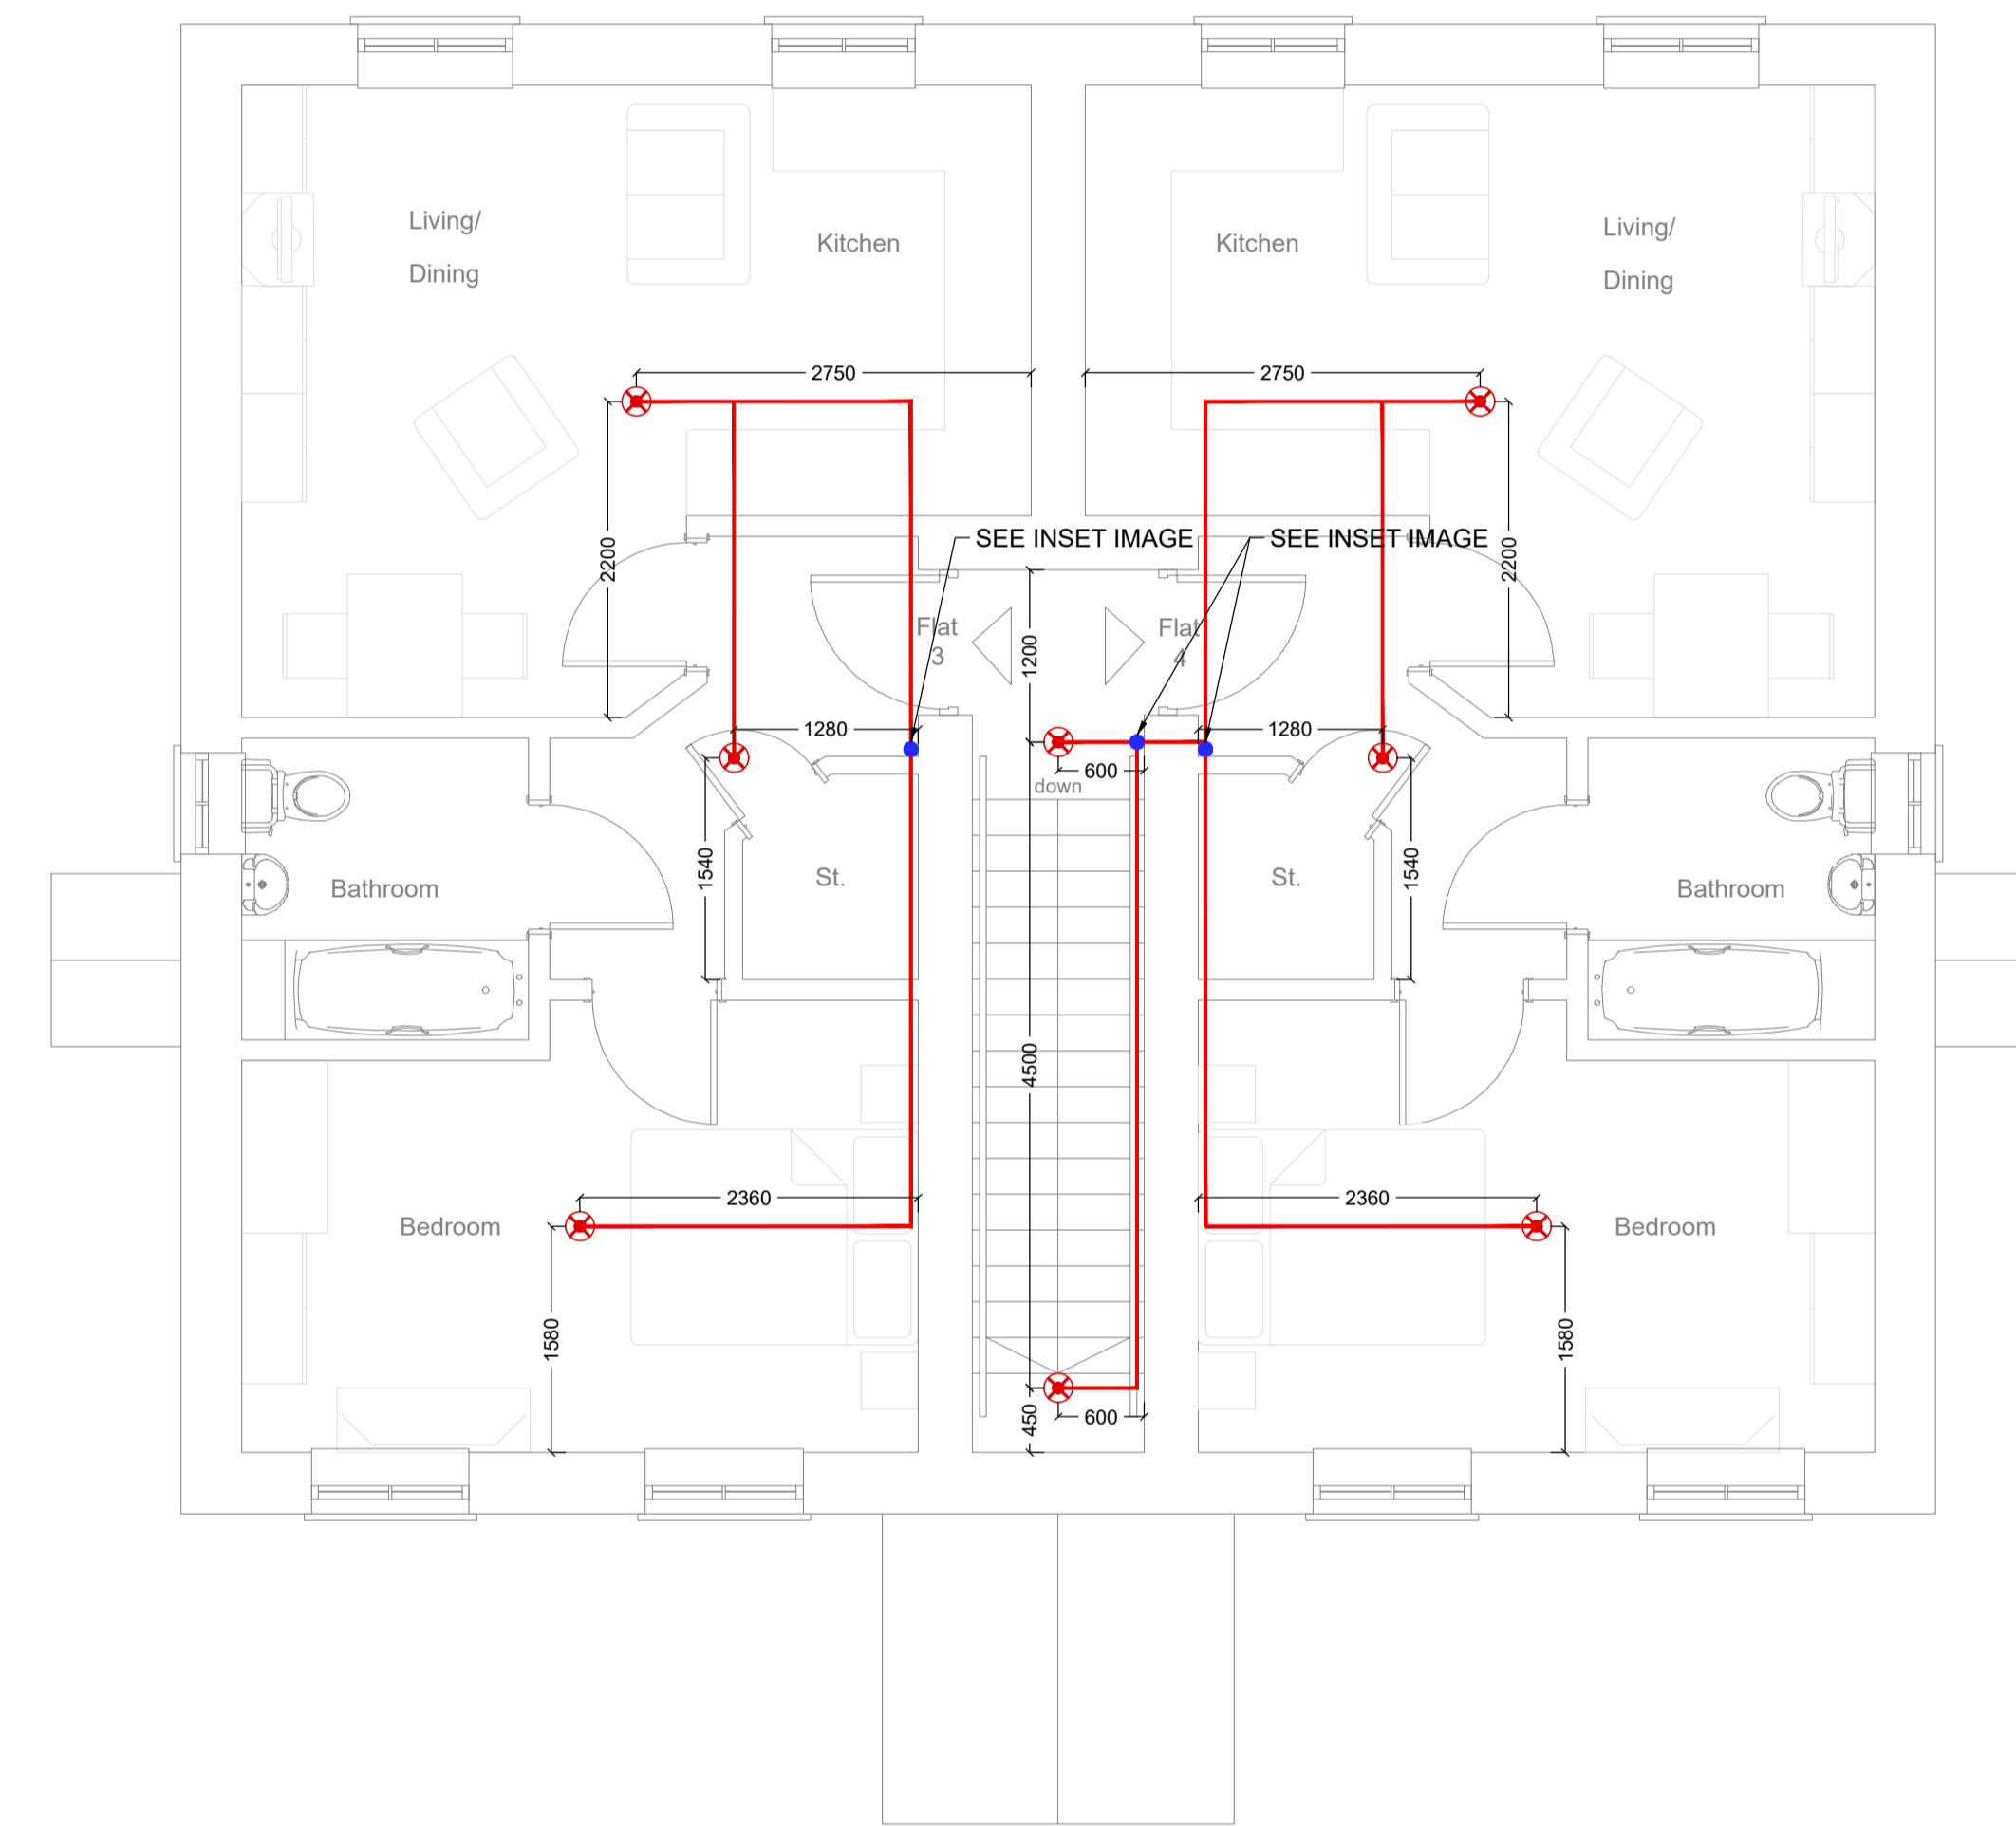

First Floor

Rev	Date	Details	Chkd

**ADVANCED FIRE TECHNOLOGIES**  
*Protection by professionals*

Advanced Fire Technologies  
Unit J, Trecenydd Business Park Tel: 0844 911 999 1  
Cierphilly Mid Glamorgan www.residentialfiresprinklers.co.uk  
CF83 2RZ



Client

**RESIDENTIAL DEVELOPMENT,  
WEMBLEY**

Drawing Status  
**WORKING DRAWING**

Date	Scale	Drawn	Checked	Approved
12.01.2018	1:50 @A1	OCS/GB	GL	AM

Project Title  
**RESIDENTIAL DEVELOPMENT  
WEMBLEY**

Drawing Title  
**GROUND & FIRST FLOOR  
SPRINKLER LAYOUT**

Drawing Number	Rev
AFT-M-001	-